

 GREEN AREA AT PRIMARY ZONE


 GREEN AREA NOT AT PRIMARY ZONE

 VERTICAL GREENING AT PRIMARY ZONE

 COVERED GREEN AREA AT PRIMARY ZONE

 IRRIGATION POINT

 PLANTER DRAIN POINT

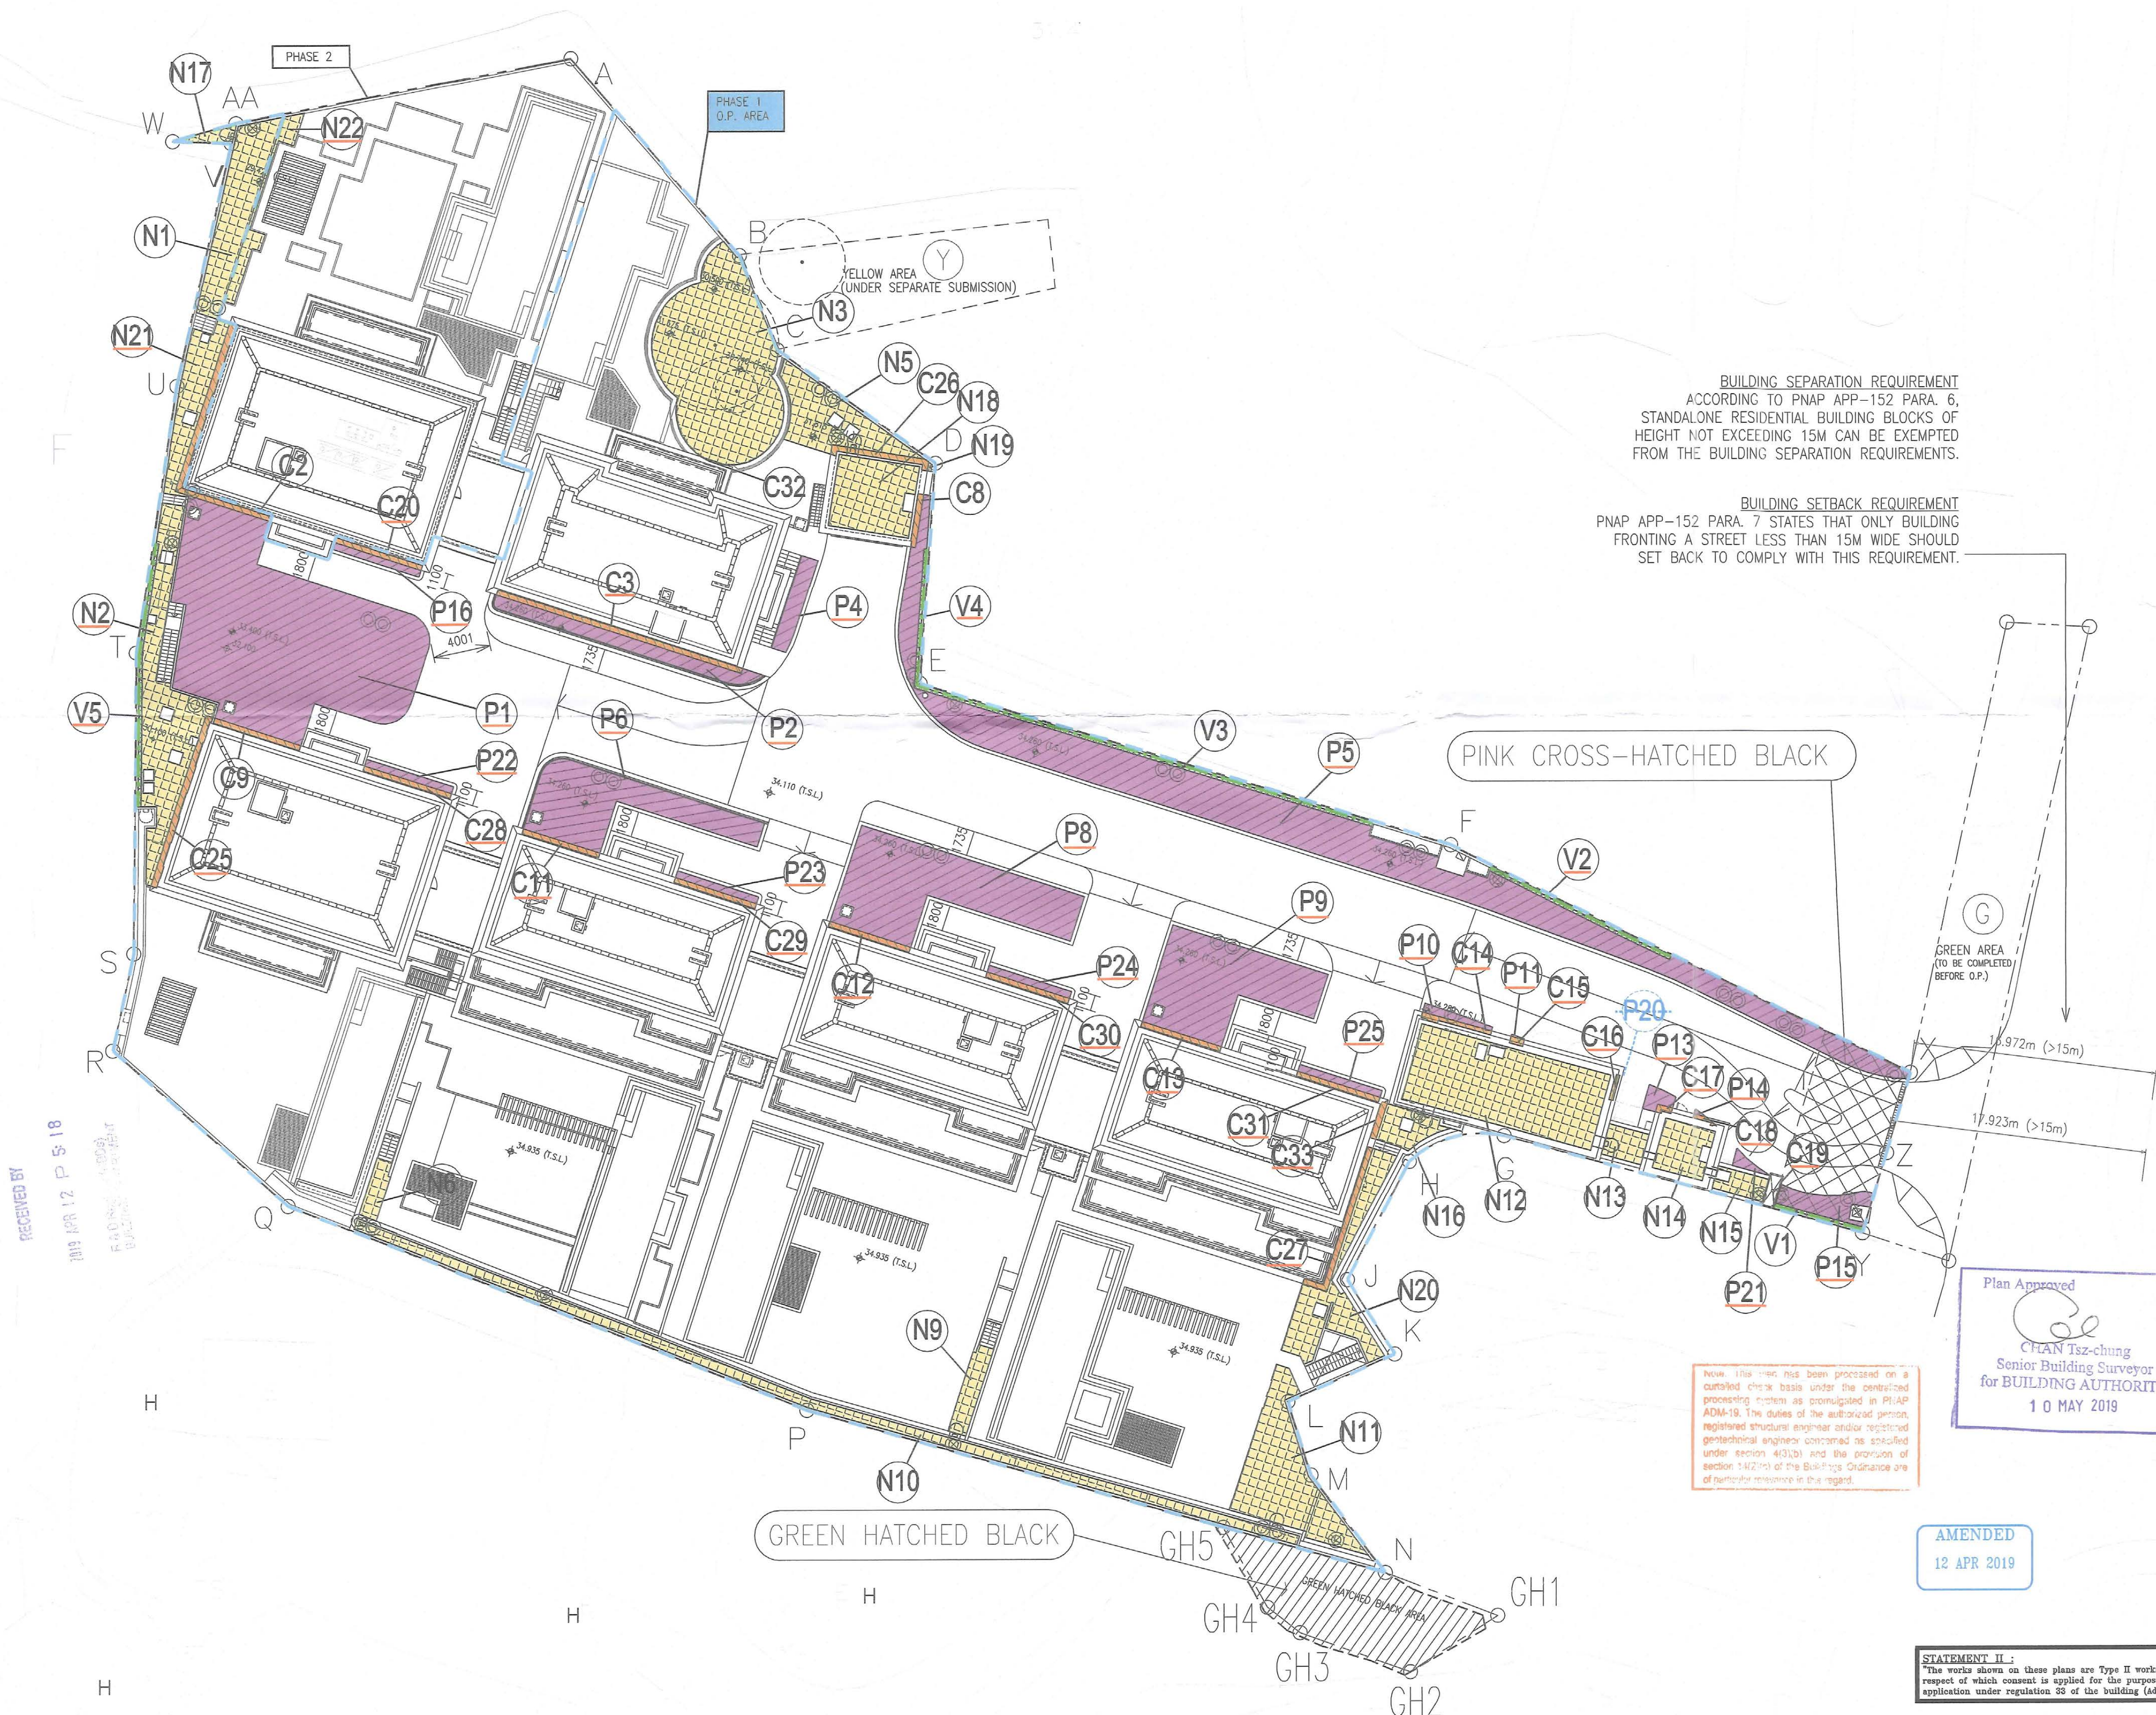

BUILDING SEPARATION REQUIREMENT
ACCORDING TO PNAP APP-152 PARA. 6,
STANDALONE RESIDENTIAL BUILDING BLOCKS OF
HEIGHT NOT EXCEEDING 15M CAN BE EXEMPTED
FROM THE BUILDING SEPARATION REQUIREMENTS.

BUILDING SETBACK REQUIREMENT
PNAP APP-152 PARA. 7 STATES THAT ONLY BUILDING
FRONTING A STREET LESS THAN 15M WIDE SHOULD
SET BACK TO COMPLY WITH THIS REQUIREMENT.

PINK CROSS-HATCHED BLACK

Plan Approved



CHAN Tsz-chung
Senior Building Surveyor
for BUILDING AUTHORITY

10 MAY 2019

AMENDED
12 APR 2019

STATEMENT II :
"The works shown on these plans are Type II works (Building Works) in respect of which consent is applied for the purpose of fast track consent application under regulation 33 of the building (Administration) regulations."

PHASE 1 & 2		PHASE 1 ONLY
SITE AREA = 6408 m2		PHASE 1 NOTIONAL SITE AREA = 5689 m2
GREEN AREA AT PRIMARY ZONE (sqm)		
P1	183.535	183.535
P2	17.536	17.536
P4	7.952	7.952
P5	172.114	172.114
P6	47.772	47.772
P8	74.674	74.674
P9	58.228	58.228
P10	2.380	2.380
P11	0.098	0.098
P13	2.482	2.482
P14	0.153	0.153
P15	9.053	9.053
P16	3.141	3.141
P21	1.471	1.471
P29	0.247	0.247
P22	3.147	3.147
P23	2.981	2.981
P24	2.982	2.982
P25	2.982	2.982
V1	6.315 x 2.500 = 15.787	15.787
V2	14.074 x 2.500 = 35.185	35.185
V3	33.230 x 2.500 = 83.076	83.076
V4	9.593 x 2.500 = 23.983	23.983
V5	18.500 x 2.500 = 46.250	46.250
C2	7.671 / 2 = 3.835	3.835
C3	8.438 / 2 = 3.220	3.220
C8	1.391 / 2 = 0.695	0.695
C9	2.242 / 2 = 1.121	1.121
C11	1.986 / 2 = 0.993	0.993
C12	2.078 / 2 = 1.039	1.039
C13	2.058 / 2 = 1.029	1.029
C14	1.582 / 2 = 0.791	0.791
C15	0.454 / 2 = 0.227	0.227
C16	0.500 / 2 = 0.250	0.250
C17	0.484 / 2 = 0.242	0.242
C18	0.366 / 2 = 0.183	0.183
C19	0.127 / 2 = 0.064	0.064
C20	2.263 / 2 = 1.132	1.132
C25	5.108 / 2 = 2.554	2.554
C26	2.827 / 2 = 1.414	1.414
C27	4.220 / 2 = 2.110	2.110
C28	2.267 / 2 = 1.129	1.129
C29	2.138 / 2 = 1.069	1.069
C30	2.139 / 2 = 1.069	1.069
C31	2.139 / 2 = 1.069	1.069
C32	0.143 / 2 = 0.071	0.071
C33	0.917 / 2 = 0.458	0.458
TOTAL	822.726	822.726
GREEN AREA NOT AT PRIMARY ZONE (sqm)		
N1	31.383	31.383
N2	49.167	49.167
N3	96.842	96.842
N5	25.523	25.523
N6	5.237	5.237
N9	8.139	8.139
N10	45.672	45.672
N11	45.161	45.161
N12	73.340	73.340
N13	6.163	6.163
N14	11.982	11.982
N15	5.175	5.175
N16	8.739	8.739
N17	2.966	2.966
N18	27.280	27.280
N19	0.145	0.145
N20	27.840	27.840
N21	18.990	18.990
N22	8.409	---
TOTAL	498.152	498.743
TOTAL GREENEERY AREA (AT PRIMARY ZONE) = 822.726 m2	TOTAL GREENEERY AREA (AT PRIMARY ZONE) = 822.726 m2	
REQUIRED GREENEERY AREA (AT PRIMARY ZONE) 6,408 x 10% = 640.800 m2 (REQUIRED)	REQUIRED GREENEERY AREA (AT PRIMARY ZONE) 5,689 x 10% = 568.900 m2 (REQUIRED)	
TOTAL GREENEERY AREA (OVERALL) = 822.726 + 498.152 = 1320.878 m2	TOTAL GREENEERY AREA (OVERALL) = 822.726 + 498.743 = 1312.469 m2	
REQUIRED GREENEERY AREA (OVERALL) 6,408 x 20% = 1,281.600 m2 (REQUIRED)	REQUIRED GREENEERY AREA (OVERALL) 5,689 x 20% = 1,139.800 m2 (REQUIRED)	

B.D. REFERENCE		BD 2/9188/15		屋宇署檢閱	
F.S.D. REFERENCE		FP 8/30767		消防處檢閱	
W.W.O. REFERENCE				水務署審閱	
CAD FILE NAME		樓宇編號			
H:\Dwgs\ACAD\Submission Plans (GBP)\2019-2014-12 (GBP-Amendment-J)\(Phase 1 & 2)\G-15 Greenery.dwg					
NOTES		注釋			
PHASE 1 O.P. CALCULATION PHASE 1 O.P. EXTENT					
NO. 修訂號	REVISONS 修訂內容	DATE 日期	BY 經手		
A	GENERAL REVISION	10-2016			
B	GENERAL REVISION	03-2017			
C	GENERAL REVISION	05-2017			
D	GENERAL REVISION	11-2017			
E	GENERAL REVISION	04-2018			
F	GENERAL REVISION	09-2018			
G	GENERAL REVISION	02-2019			
<u>H</u>	<u>GENERAL REVISION</u>	<u>04-2019</u>			



DLN

DLN

DLN

Denise Lee & Ng Chun Man
Architects & Engineers (WV) Ltd
建築師伍振昌
陳錦強等(香港)有限公司
+ 852 2855 6888 | + 852 2576 4074

46-47 Floor, Tower One, Times Square
Maheon Street, Causeway Bay, Hong Kong
香港銅鑼灣時代廣場
時代廣場一座 46至47座
email general@dlm.com.hk www.dlm.com.hk

Dennis Lau Wing-king 劉展榮 JP
BA(HK), HKMA, RBA, FRA, AP(Architect), Registered Architect

Alaots Wong Wing-yim 王明發
BA(HK), HKMA, RBA, FRA, AP(Architect), Registered Architect, LEED® AP, BEAM Professional
China Green Building Council OIB Manager

Henry Lau King-chu 劉錦釗
BA(S)/Hons(HK), BA(ArchD)(UK), HKMA, RBA, ARMA, ACQAP
(Architect), Registered Architect

Chung Kwong-ching 黃國榮
BA(HK)(Hons), HKMA, RBA, FRA, ARMA
PRC Class 1 Registered Architect Qualification (AP/Architect)
Registered Architect, BEAM Professional
China Green Building Council OIB Manager

Arthur Au Kin-tung 歐冠雄
BA(HK)(Hons), HKMA, RBA, FRA, AP(Architect)
Registered Architect, BEAM Professional

David Chan Chi-ting 陳智強
BA(HK)(Hons), HKMA, RBA, FRA, AP(Architect)
PRC Class 1 Registered Architect Qualification
AP (Architect), Registered Architect, BEAM Professional
China Green Building Council OIB Manager

Joseph Tang Chun-sing 鄧楚庭
BA(HK)(Hons), HKMA, RBA, FRA, AP(Architect)
Registered Architect, BEAM Professional

Ivan Ng Yau-man 吳國文
BA(HK)(Hons), HKMA, RBA, FRA, AP(Architect), Registered Architect
LEED® AP, BEAM Professional, China Green Building Council OIB Manager

Phylona Au Yeung Ming-ae 歐陽明詩
AA, HKIA, PRC Class 1 Registered Architect Qualification
Registered Architect (Shanghai), HKMA, RBA, FRA, AP(Architect), Registered Architect(HK)
BEAM (Architect), BSSG(Architect), LEED® AP, BEAM Professional

Carolyn Fung Shue-yuen 方麗蓮
BA(HK)(Hons), HKMA, RBA, FRA, AP(Architect), Registered Architect
PRC Class 1 Registered Architect Qualification (AP/Architect)
Registered Architect, LEED® AP, BEAM Professional, China Green Building Assessment
LEED® AP, Green Building Faculty Member
China Green Building Council OIB Manager

Jackson Pang Yuh-hong 彭宇豪
BA(US)(Hons), BERKELEY (US), MArch(HK), HKIA
PRC Class 1 Registered Architect Qualification
AP(Architect), Registered Architect, LEED® AP, BEAM Professional
China Green Building Council OIB Manager

Daniel Chan Yiu-yung 陳耀揚
BA(HK)(Hons), MArch(HK)
PRC Class 1 Registered Architect Qualification
HKIA, Registered Architect, LEED® AP, BEAM Professional
China Green Building Council OIB Manager

Alexander Luen 廖國大 香港特約
BA(HK), HKMA, RBA, FRA, AP(Architect), Registered Architect (HKMA & US)

Christine Kwun Shi-yi 關志怡
BA(HK)(Hons), HKMA, RBA, FRA, AP(Architect), Registered Architect
LEED® AP, BEAM Professional

ALL MEASUREMENTS MUST BE CHECKED AT THE WORK BY THE CONTRACTOR
所有尺寸應由承建商於工地核實

DO NOT SCALE FROM DRAWINGS 尺寸不準由圖紙直接量度

ALL PRINTS, SPECIFICATIONS AND THEIR COPYRIGHT ARE THE PROPERTY OF
THE ARCHITECT AND SHALL BE RETURNED AT THE COMPLETION OF THE WORK
所有圖紙、規格及版權均為建築師所有，工程完竣後須交還

PROJECT	項目名稱
RESIDENTIAL RE-DEVELOPMENT LOT No. 1909 IN D.D. No. 100 FAN KAM ROAD, SHEUNG SHUI, NEW TERRITORIES	

DRAWING TITLE	標題
---------------	----

GREENERY CALCULATIONS

SCALE	比例	DATE	日期
-------	----	------	----

1:250 @A1	JAN., 2016
DRAWN BY 製作人	CHECKED BY 検査

KS	CF
----	----

N2021-H	G-15 <u>H</u>
---------	---------------

FOR B.D. APPROVAL